


- ① PUMP CONTROLLER - APPROX 14"W x 16"H (BY COLLECTION SYSTEM CONTRACTOR)
- ② ALARM LIGHT (INCLUDED ON CONTROL PANEL)
- ③ CABLE (SEE SCHEMATIC) FROM HOUSE PANEL (BY OWNER'S CONTRACTOR)
- ④ CABLE TO PUMP (BY COLLECTION SYSTEM CONTRACTOR)

MDA Consulting Engineers, PLLC
 3 Bristol Lane
 Ellcottville, NY 14731
 Phone: (716) 699-4650

PROJECT Lime Lake Sewer District SHEET NO. 1 OF 1
 SUBJECT Step 3 Electric Installation: Elevation View - Typical Installation SCALE N.T.S.
 ORIGINAL BY DTR DATE 4/18/2018 CHK. BY CDH DATE 4/18/2018
 FILE PATH k:\project files\2011\11201 - t. machias llsd - basic design\dwg\11201 - 2018.04.18 - electrical details.dwg

**NOT TO
 SCALE**

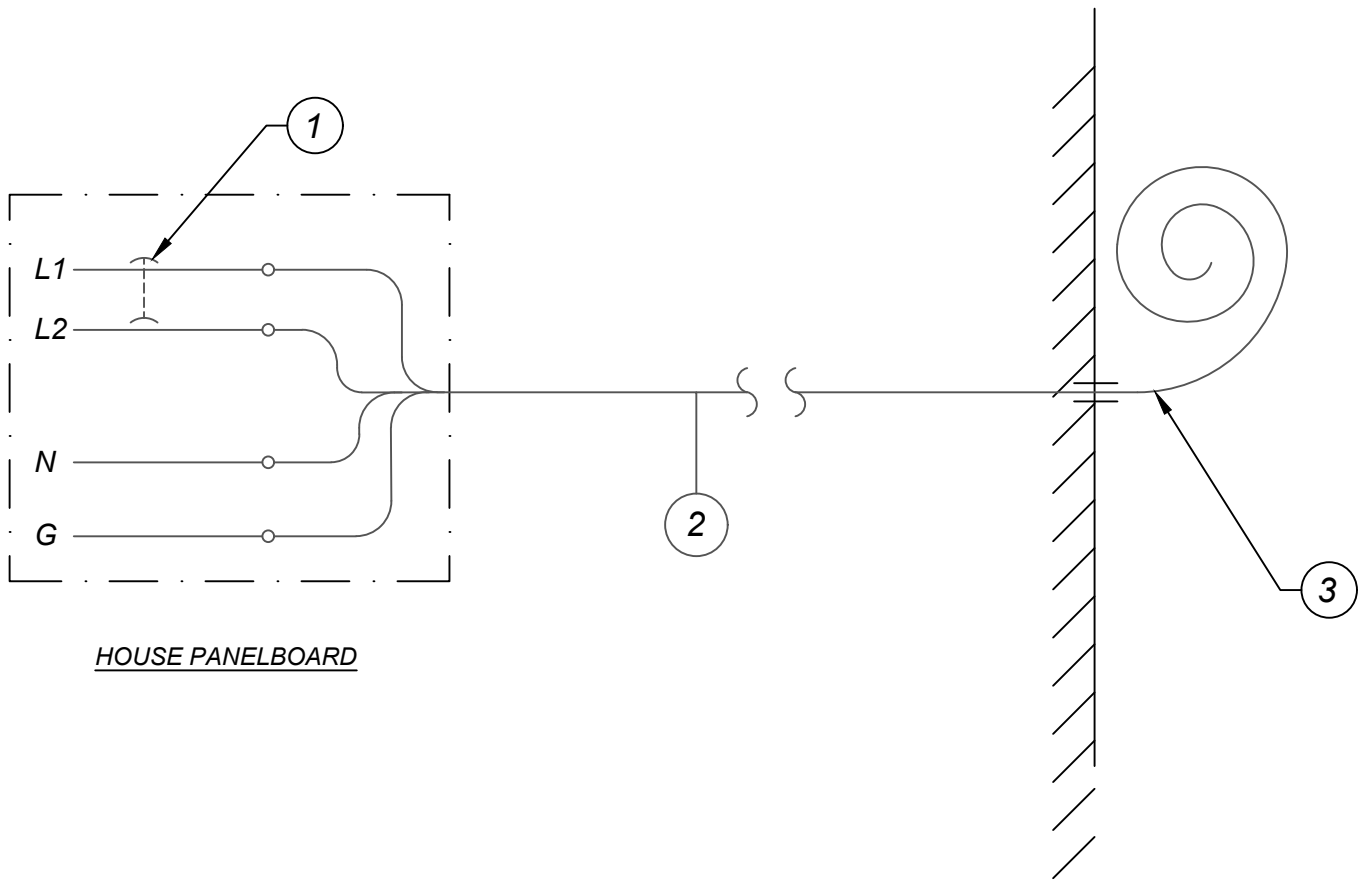

- ① DEDICATED 30-AMP, 2-POLE CIRCUIT BREAKER (BY OWNER'S CONTRACTOR)
- ② FOUR (4) #10 AWG CONDUCTORS IN CONDUIT OR 10/3 (WITH GROUND) TYPE NM CABLE (BY OWNER'S CONTRACTOR)
- ③ THROUGH EXTERIOR WALL NEAR THE LOCATION OF THE SEWER PIPE PENETRATION THROUGH EXTERIOR WALL. OWNER'S CONTRACTOR SHALL INSTALL ELECTRICAL WIRING IN COMPLIANCE WITH LOCAL CODE. LEAVE 10 FEET OF CABLE SLACK FOR TERMINATION BY COLLECTION SYSTEM CONTRACTOR.

MDA Consulting Engineers, PLLC
 3 Bristol Lane
 Ellicottville, NY 14731
 Phone: (716) 699-4650

PROJECT Lime Lake Sewer District SHEET NO. 1 OF 1
 SUBJECT Step 3 Electrical Modifications Schematic View SCALE N.T.S.
 ORIGINAL BY DTR DATE 4/18/2018 CHK. BY CDH DATE 4/18/2018
 FILE PATH k:\project files\2011\11201 - t. machias llsd - basic design\dwg\11201 - 2018.04.18 - electrical details.dwg

**NOT TO
 SCALE**